


GUYANA POWER AND LIGHT INC.  
FACILITIES MANAGEMENT

1	1	1
2	2	2
3	3	3
4	4	4
5	5	5
6	6	6
7	7	7
8	8	8
9	9	9
10	10	10
11	11	11
12	12	12

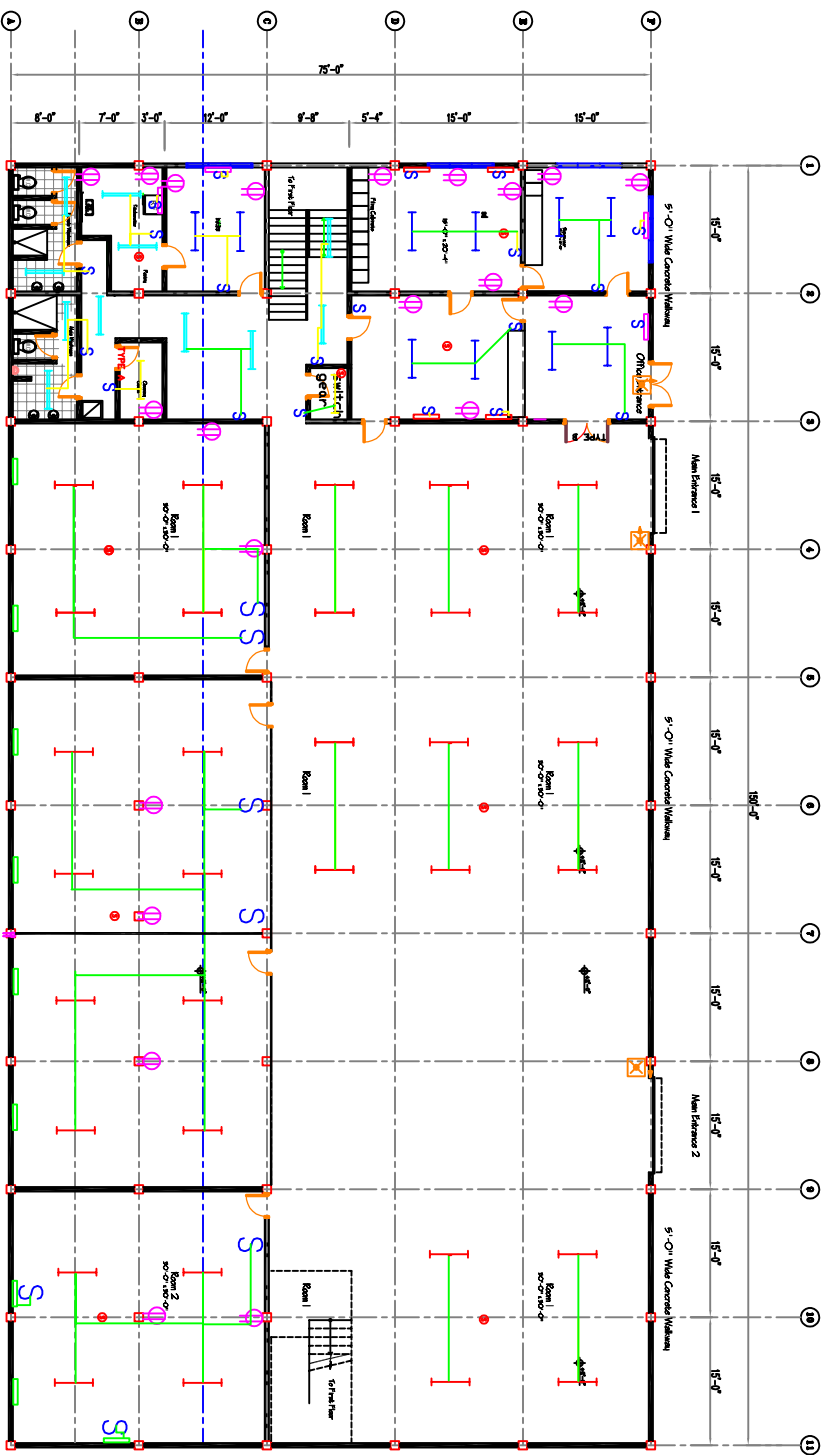

**GROUND FLOOR ELECTRICAL PLAN**

No.	Description	Date
-----	-------------	------

SOPHIA STORES BUILDING

Ground floor electrical plan

Project Number	05 Sep 2022
Date	
Drawn By	K. Sivaraman
Checked By	J. Hargreaves

#12